



AUD

AMERICAN  
UNIVERSITY  
IN DUBAI

# Bathroom Charrette

Studio 6

Professor - Kristin Lee

Shea Neil

1605028965

An ember is a bright piece of wood, or coal that glow for some time and exude warmth. My concept for this ADA bathroom is to have a space that is not only practical, and functional, but also aesthetic and comforting, which is a factor commonly ignored.

The space is cozy and is divided, with the center being empty, like with a bonfire. The main materials used are concrete, slate, copper, wood, and tiles, to represent the firewood, the ash and the ember itself. Copper is used here to bring attention to grab bars and to the bathroom accessories, instead of trying to hide it. The bathroom also uses warm and even lighting to help provide such an ambience, while also helping the visually challenged. This space is rather linear and minimalistic, with dark and copper undertones to bring out the concept. The dominant colors are reds, bronze, greys, black and white. The engineered wood and slate flooring is also added to provide a tactile sense to the user as well. As most the bathroom fixtures are designed as to provide a contrast for easier access. Thus, the space is intended to provide a sense of warmth and comfort, with soft dark, and neutral tones, instead of just something sensible and institutional, without personality.

NOTES:

PROJECT TITLE:  
 BATHROOM CHARRETTE

NAME: SHEA NEIL  
 1605028965

DRAWING TITLE:  
 CONCEPT

DATE: 26/9/2019


SCALE: 1:30

PAGE: 1


# CONCEPT

# EMBER

Embers are smoldering pieces of wood or coal — that burn brightly as a fire starts to fade. It is almost symbolic of how one can shine even in the darkest of times, no matter the circumstance.

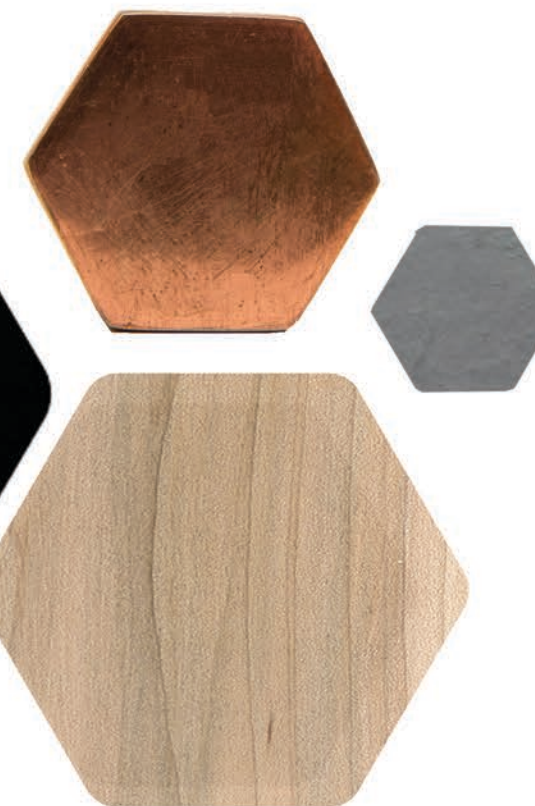

Materials used -  
 Slate, wood,  
 tile,  
 concrete,  
 granite, and  
 copper

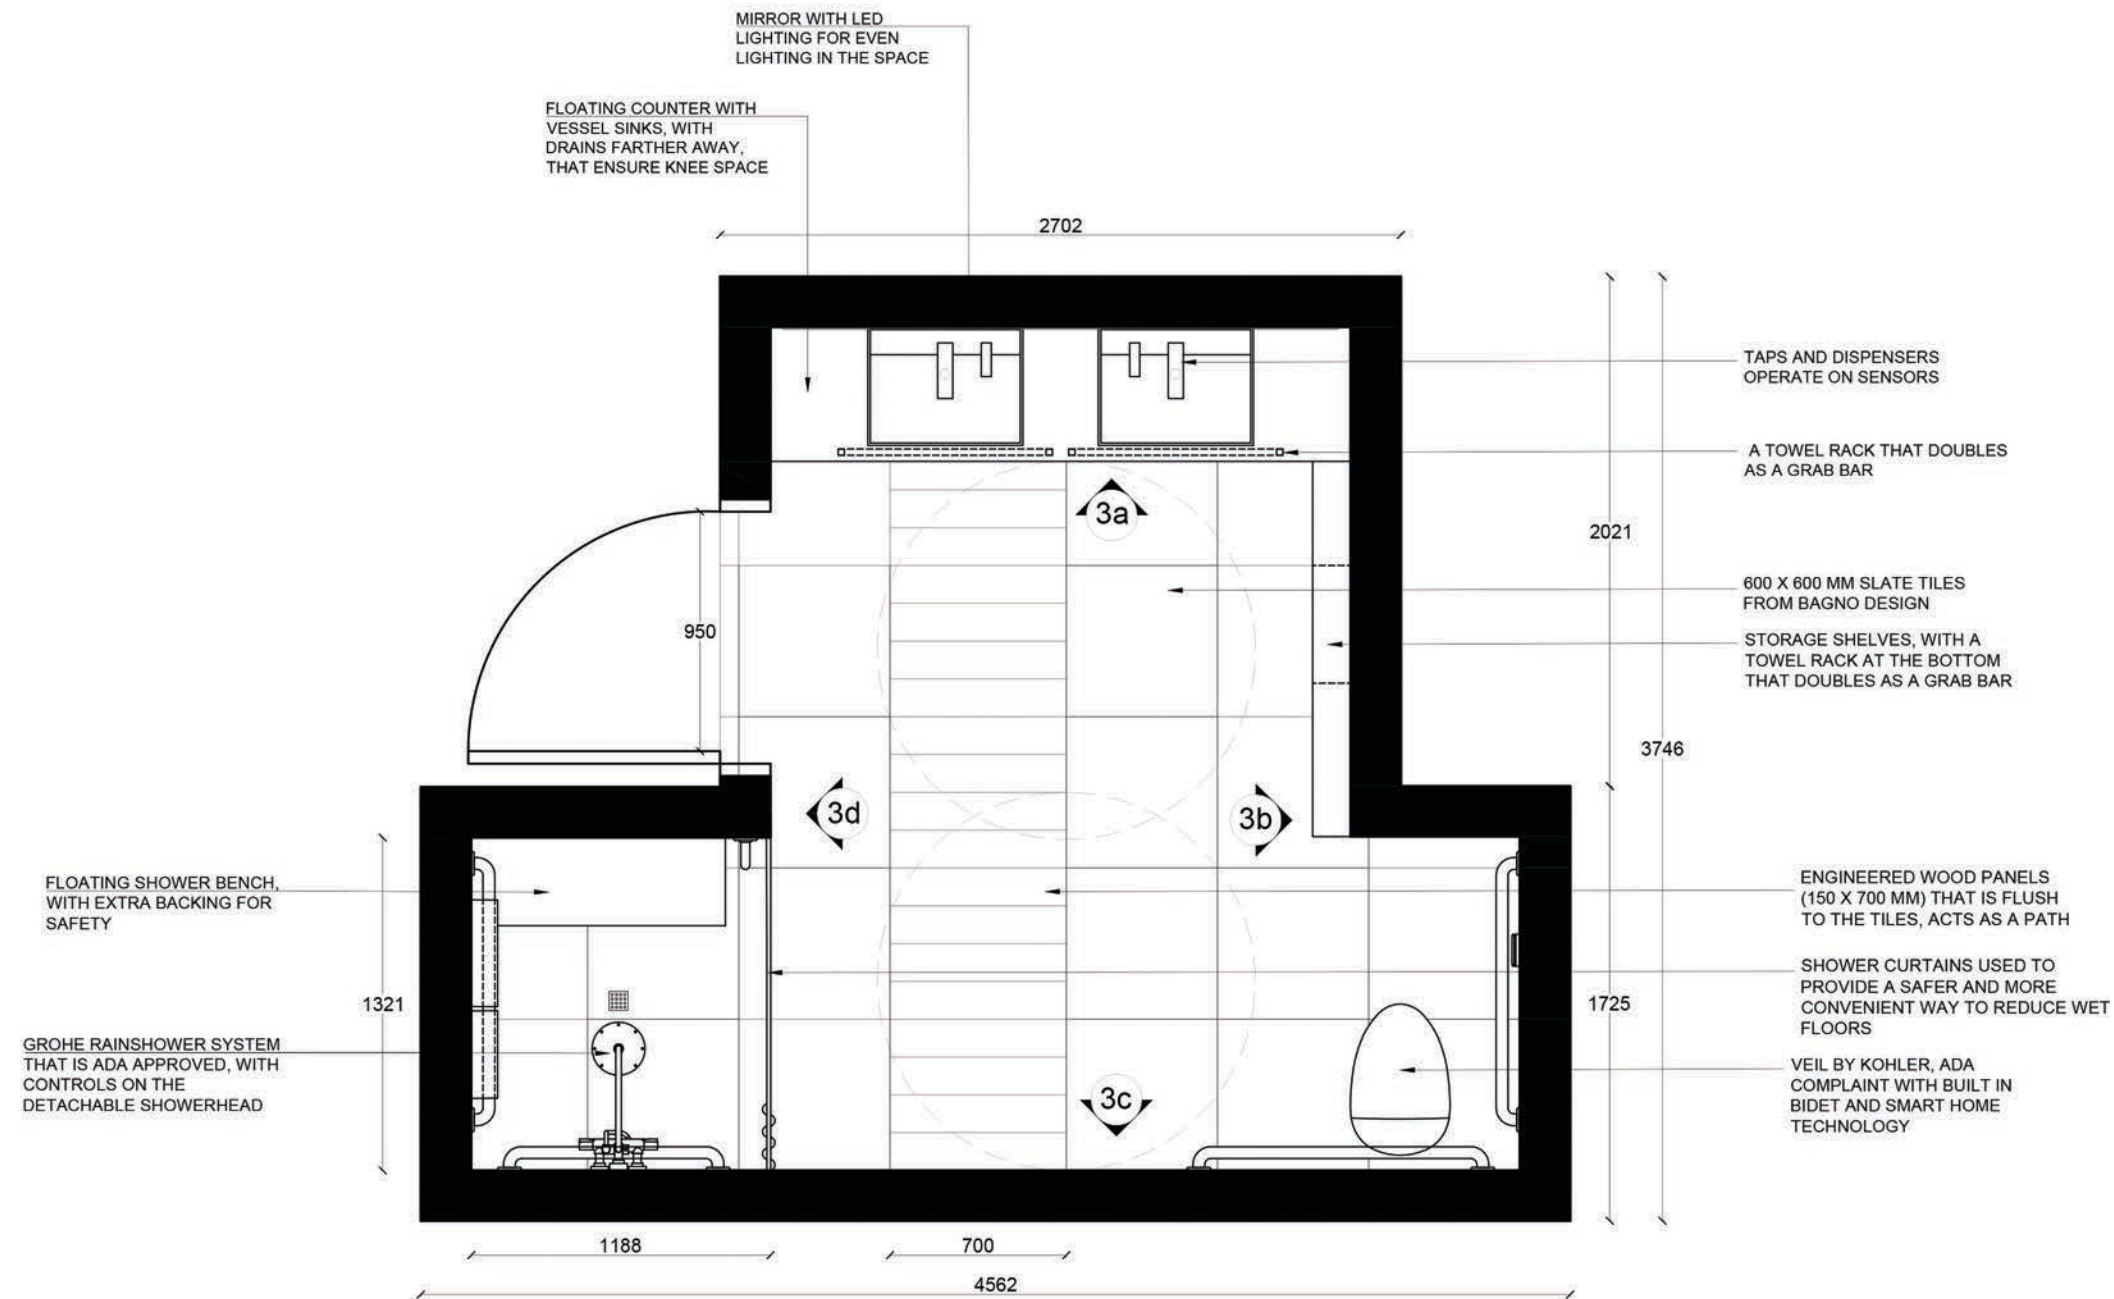

NOTES:

PROJECT TITLE:  
 BATHROOM CHARRETTE

NAME: SHEA NEIL  
 1605028965

DRAWING TITLE:  
 FLOORPLAN


DATE: 26/9/2019

SCALE: 1:30

PAGE: 2

**1** FLOOR PLAN  
 SCALE 1:30

NOTES:

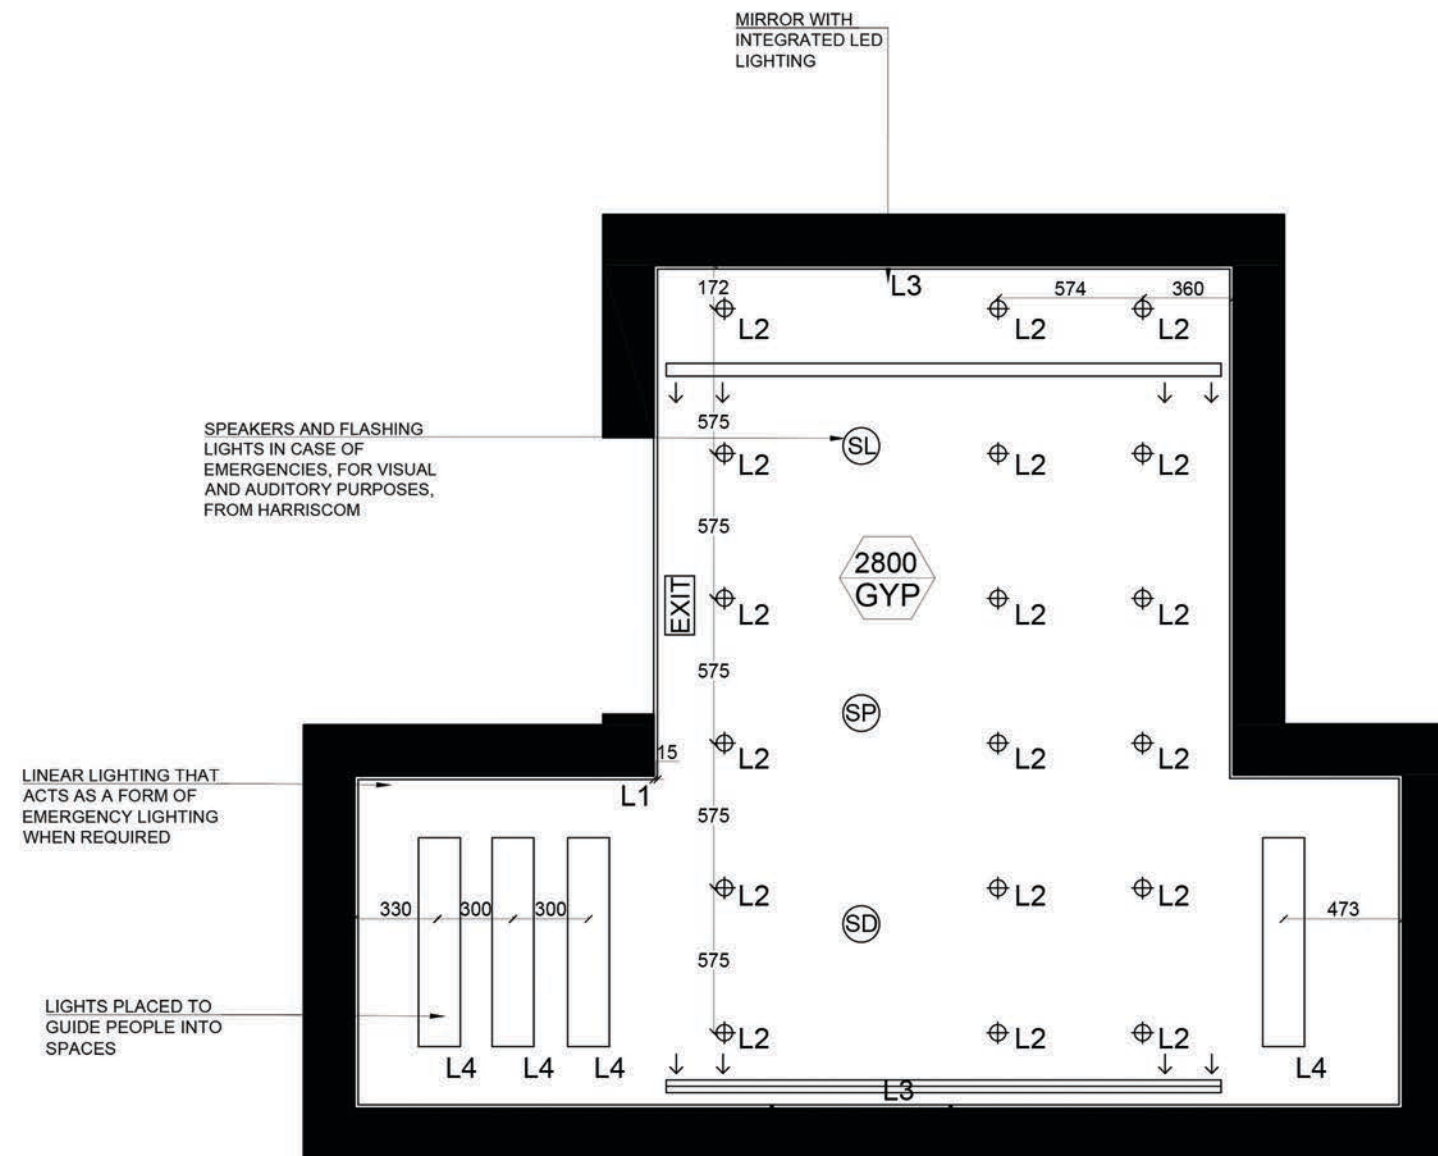

LEGEND	
FIREFIGHTING SYSTEM LEGEND	
⊕	SMOKE DETECTORS
⊕	SPRINKLERS
⊕	SPEAKERS AND LIGHTS
EXIT	EXIT LIGHTS
AC SYSTEM LEGEND	
↑	SUPPLY
↓	RETURN
LIGHTING SYSTEM LEGEND	
L1	LINEAR LIGHT
L2	RECESSED SPOTLIGHT
L3	FURNITURE INTEGRATED LIGHT
L4	RECESSED DOWN LIGHT

2

RCP  
SCALE 1:30

PROJECT TITLE:  
BATHROOM CHARRETTE

NAME: SHEA NEIL  
1605028965

DRAWING TITLE:  
RCP

DATE: 26/9/2019

SCALE: 1:30

PAGE: 3

NOTES:

PROJECT TITLE:  
 BATHROOM CHARRETTE


NAME: SHEA NEIL  
 1605028965

DRAWING TITLE:  
 ELEVATION 1

DATE: 26/9/2019

SCALE: 1:30

PAGE: 4

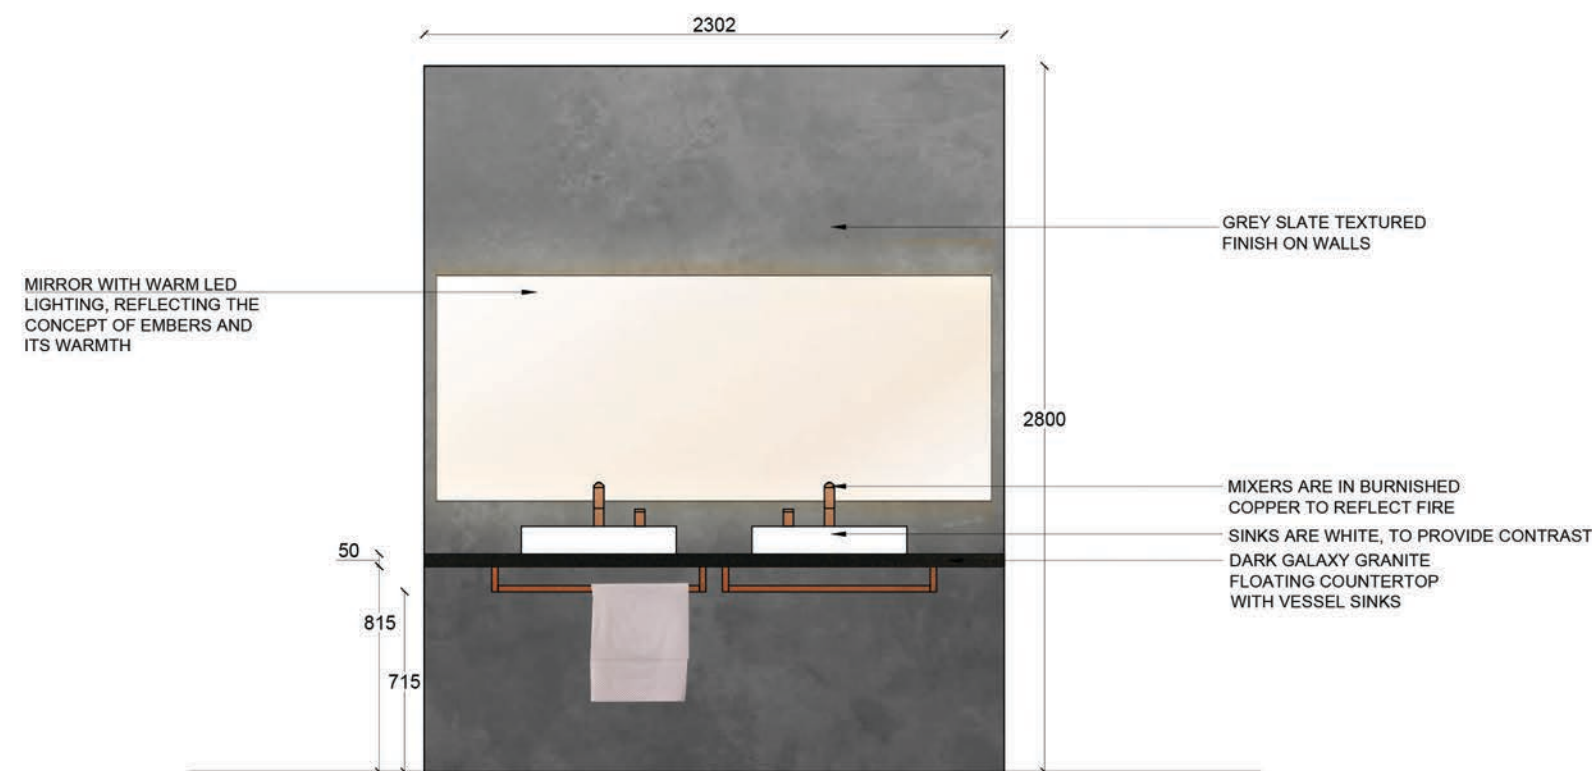

**3a** ELEVATION 1  
 SCALE 1:30

NOTES:

PROJECT TITLE:  
 BATHROOM CHARRETTE

NAME: SHEA NEIL  
 1605028965

DRAWING TITLE:  
 ELEVATION 2

DATE: 26/9/2019


SCALE: 1:30

PAGE: 4



**3b** ELEVATION 2  
 SCALE 1:30

NOTES:

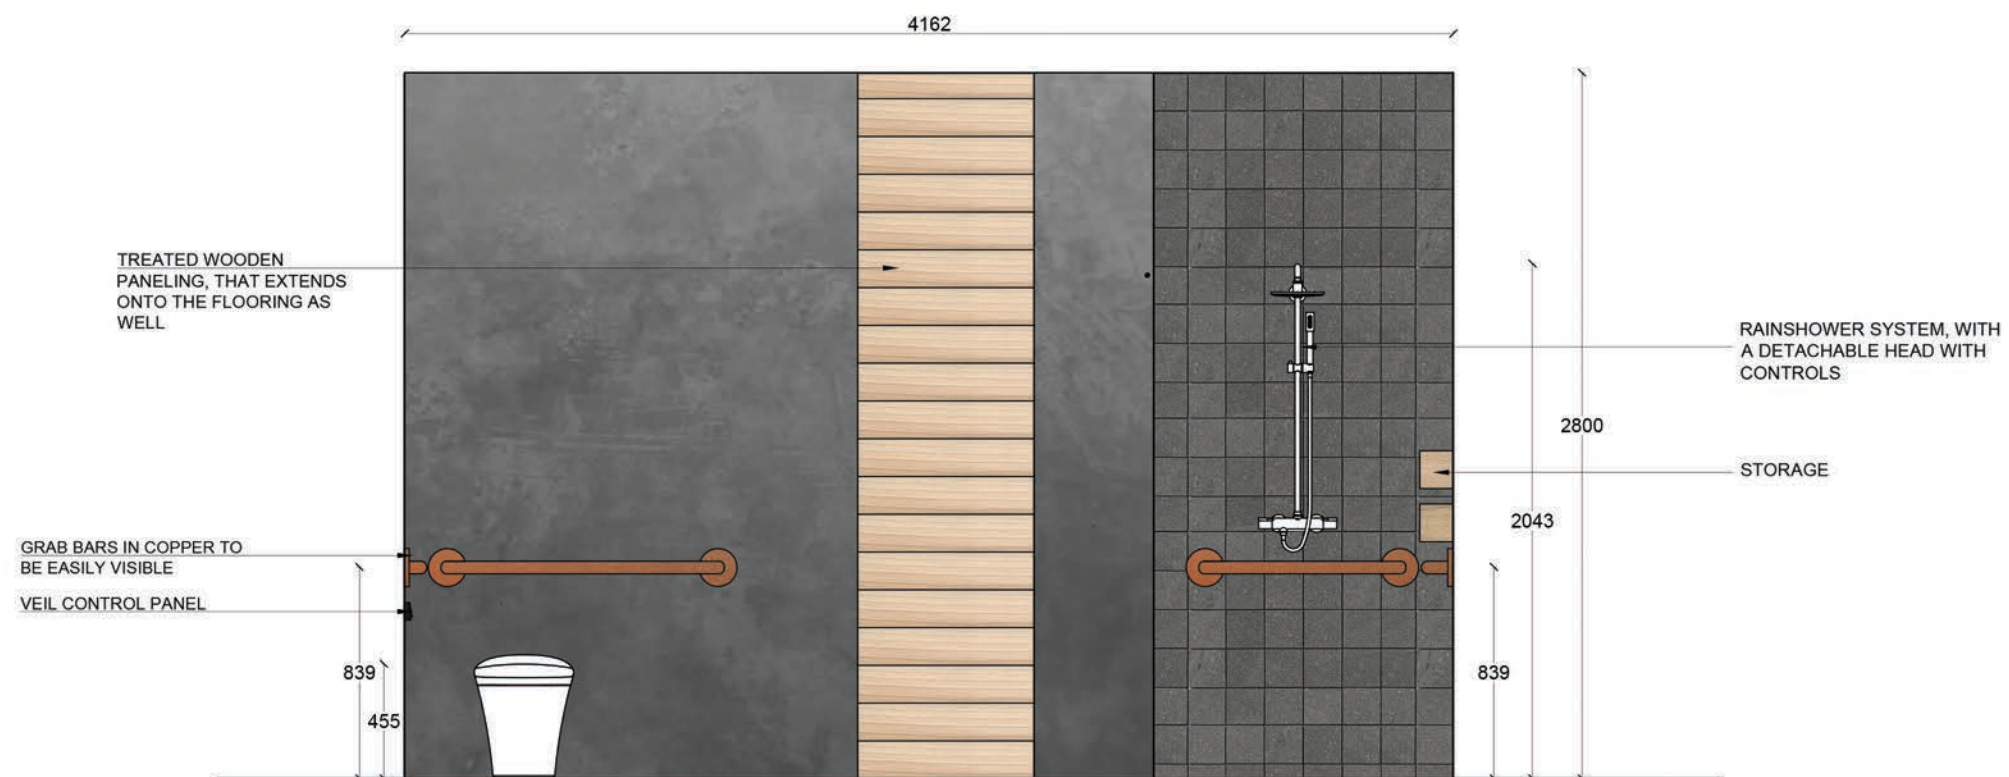

**3c** ELEVATION 3  
 SCALE 1:30

PROJECT TITLE:  
 BATHROOM CHARRETTE

NAME: SHEA NEIL  
 1605028965

DRAWING TITLE:  
 ELEVATION 3

DATE: 26/9/2019

SCALE: 1:30

PAGE: 6

NOTES:

PROJECT TITLE:  
 BATHROOM CHARRETTE


NAME: SHEA NEIL  
 1605028965

DRAWING TITLE:  
 ELEVATION 4

DATE: 26/9/2019

SCALE: 1:30

PAGE: 7

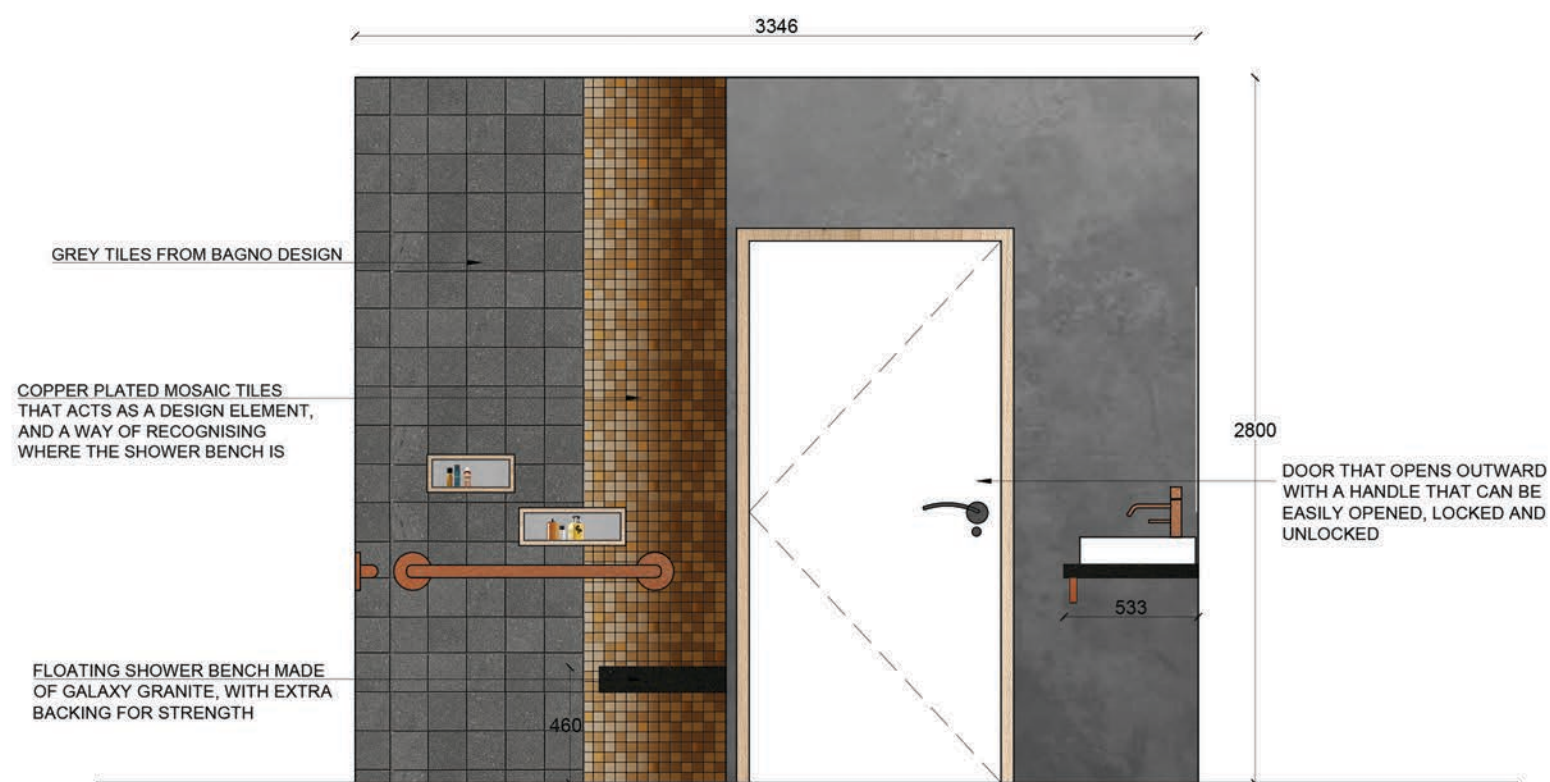

**3d** ELEVATION 4  
 SCALE 1:30



NOTES:

PROJECT TITLE:  
BATHROOM CHARRETTE

NAME: SHEA NEIL  
1605028965

DRAWING TITLE:  
RENDERS

DATE: 26/9/2019

SCALE: 1:30

PAGE: 8

